


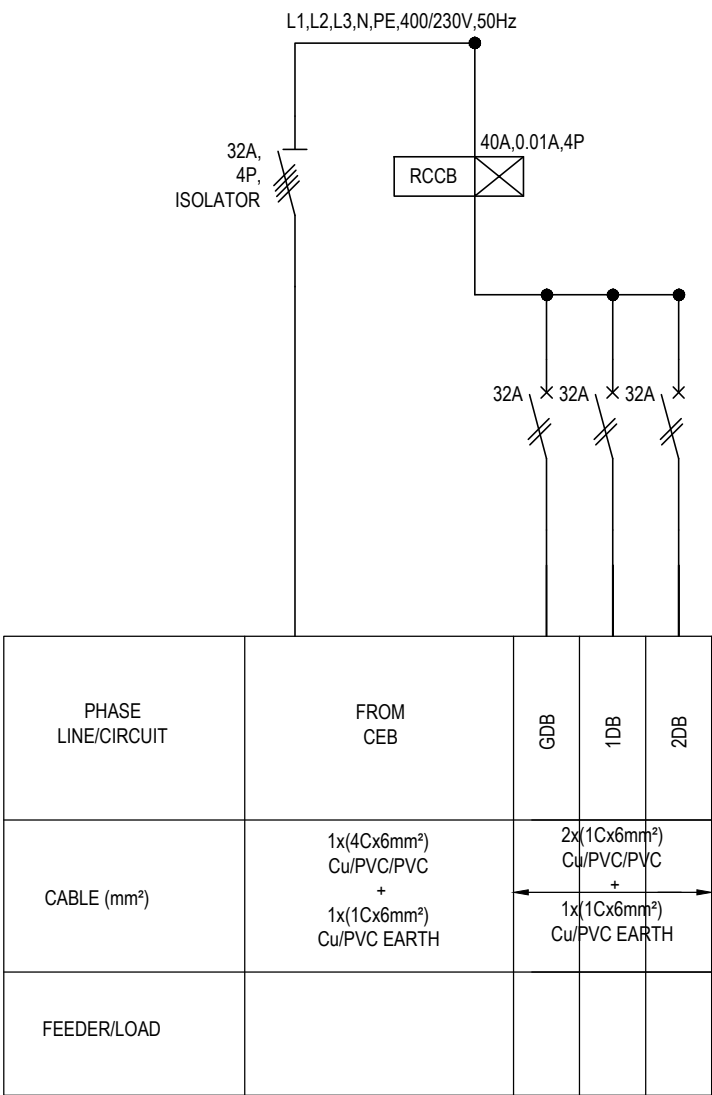

LEGEND

RCCB

—

RESIDUAL CURRENT CIRCUIT BREAKER

—

2 POLE MINIATURE CIRCUIT BREAKER (MCB)

—

4 POLE MINIATURE CIRCUIT BREAKER (MCB)

—

4 POLE ISOLATOR

Drawing Title	SINGLE LINE DIAGRAM MAIN DISTRIBUTION BOARD	Design By : J.G.D.S.DE SILVA, Electrical Engineer, Bsc(Hon), C.Eng.,MIE(SL).	Signature :	Mobile No. : 071-3121235.	Date : 13-11-2020.						
Client	ROPOSED RESIDENTIAL BUILDING FOR DR. KUMARA AT HAPUGALA, GALLE	Drawing Number ELE - SLD - 01	Scale N.T.S.	Sheet Size A3	Page Number 02	Rev	Date	Description	Stat.	Remarks	