


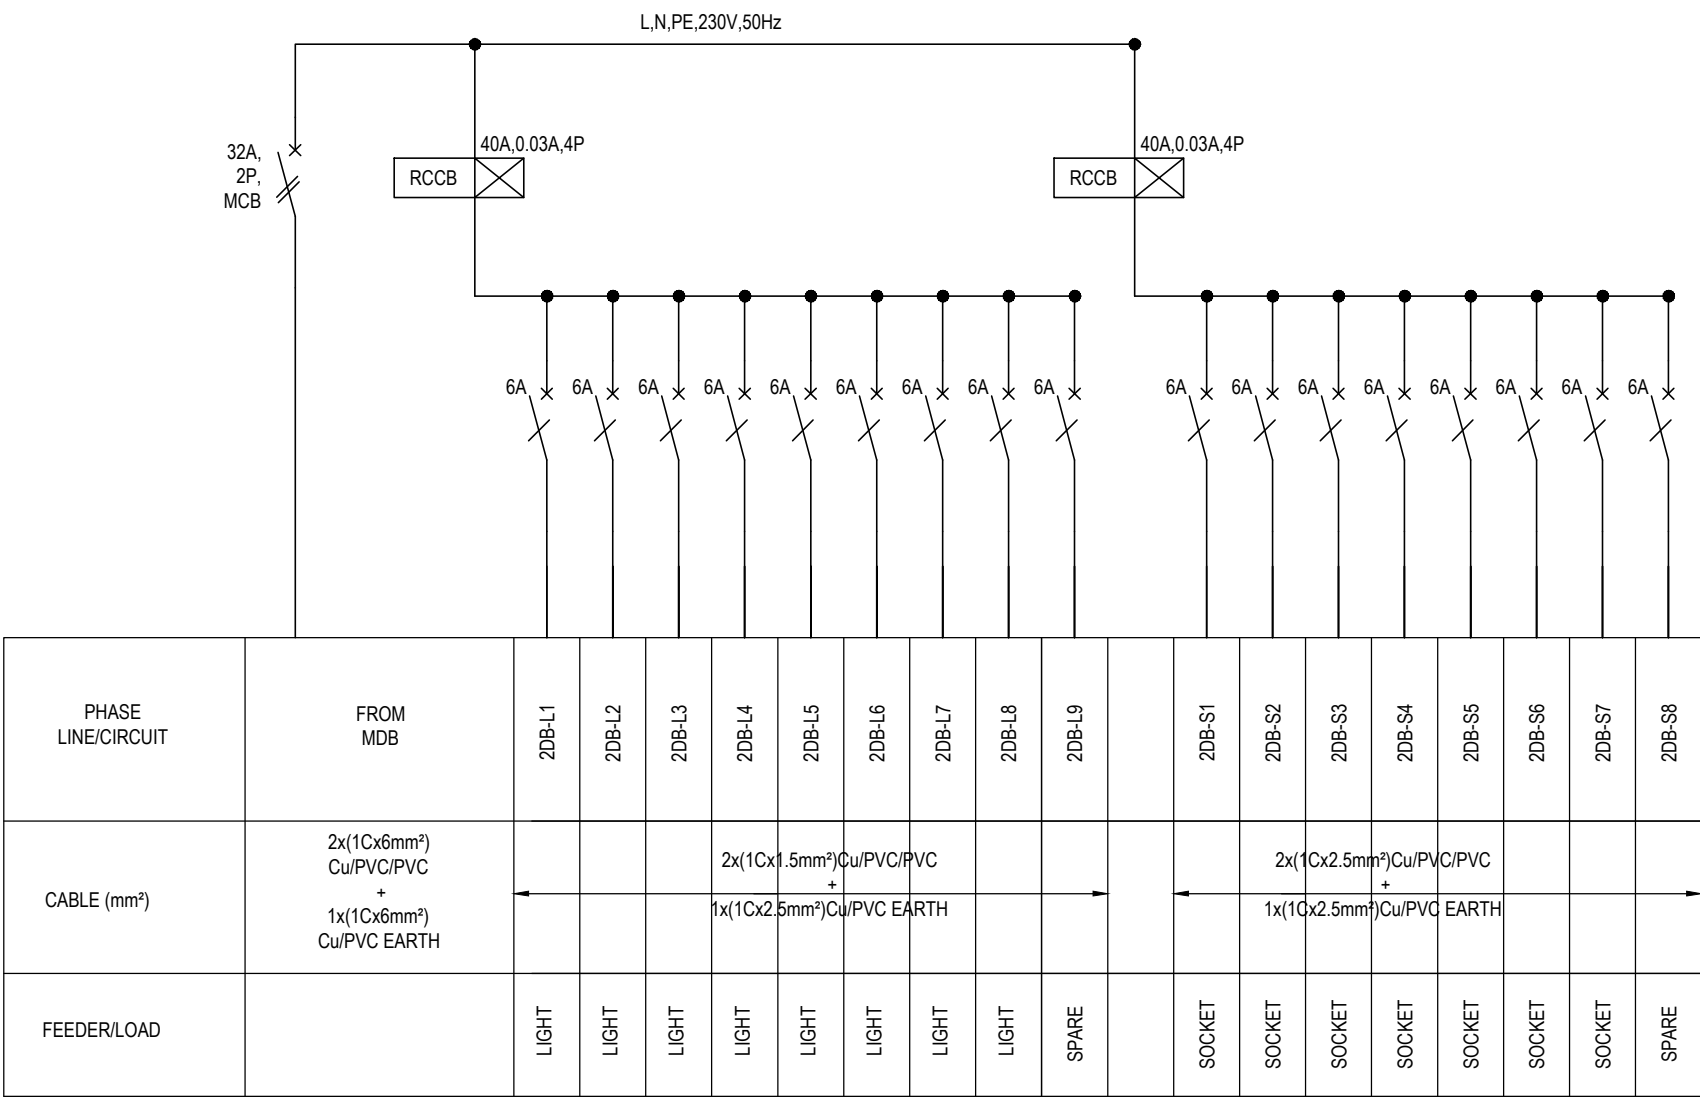

LEGEND

RCCB

—

RESIDUAL CURRENT CIRCUIT BREAKER

—

2 POLE MINIATURE CIRCUIT BREAKER (MCB)

—

4 POLE MINIATURE CIRCUIT BREAKER (MCB)

Drawing Title	SINGLE LINE DIAGRAM DISTRIBUTION BOARD FIRST FLOOR				Design By : J.G.D.S.DE SILVA, Electrical Engineer, Bsc(Hon), C.Eng.,MIE(SL).																		
Client	ROPOSED RESIDENTIAL BUILDING FOR DR. KUMARA AT HAPUGALA, GALLE				Signature :				Mobile No. : 071-3121235.				Date : 13-11-2020.										
				Drawing Number		Scale		Sheet Size		Page Number		Rev	Date	Description	Stat.	Remarks							
				ELE - SLD - 03		N.T.S.		A3		04													