


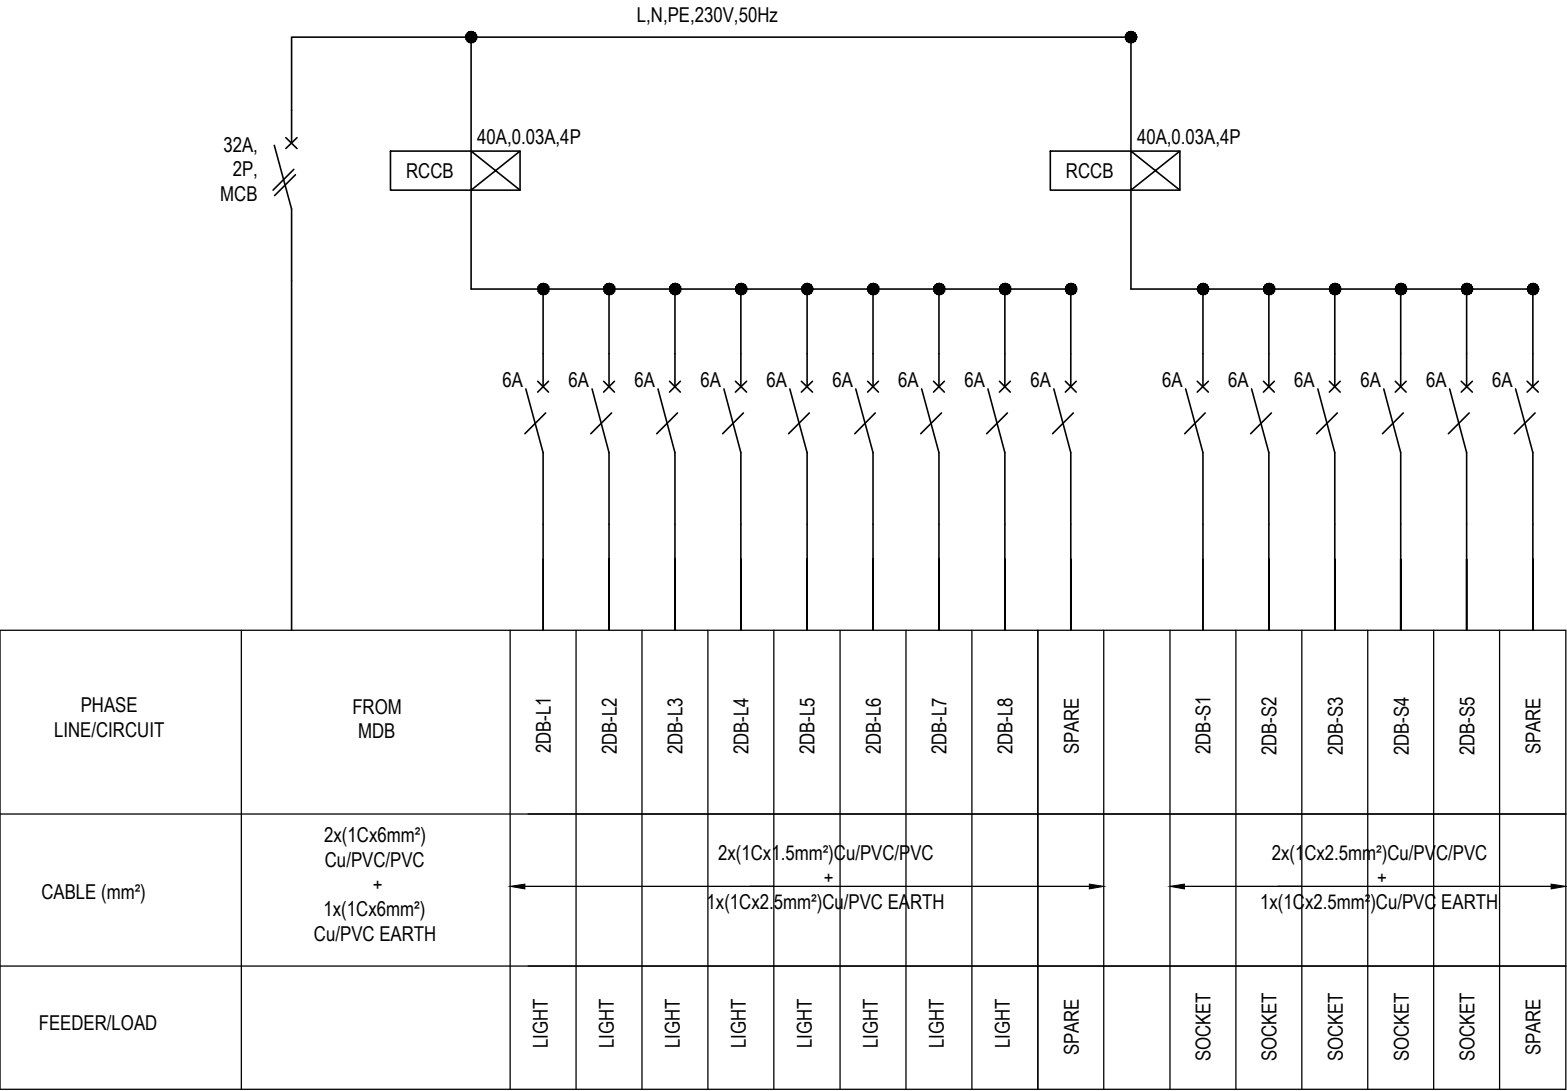

LEGEND

RCCB

—

RESIDUAL CURRENT CIRCUIT
BREAKER

—

2 POLE MINIATURE CIRCUIT
BREAKER (MCB)

—

4 POLE MINIATURE CIRCUIT
BREAKER (MCB)

Drawing Title	SINGLE LINE DIAGRAM DISTRIBUTION BOARD SECOND FLOOR				Design By : J.G.D.S.DE SILVA, Electrical Engineer, Bsc(Hon), C.Eng.,MIE(SL).										
Client	ROPOSED RESIDENTIAL BUILDING FOR DR. KUMARA AT HAPUGALA, GALLE				Signature :				Mobile No. : 071-3121235.		Date : 13-11-2020.				
Drawing Number ELE - SLD - 04				Scale N.T.S.	Sheet Size A3	Page Number 05		Rev	Date	Description	Stat.	Remarks			