


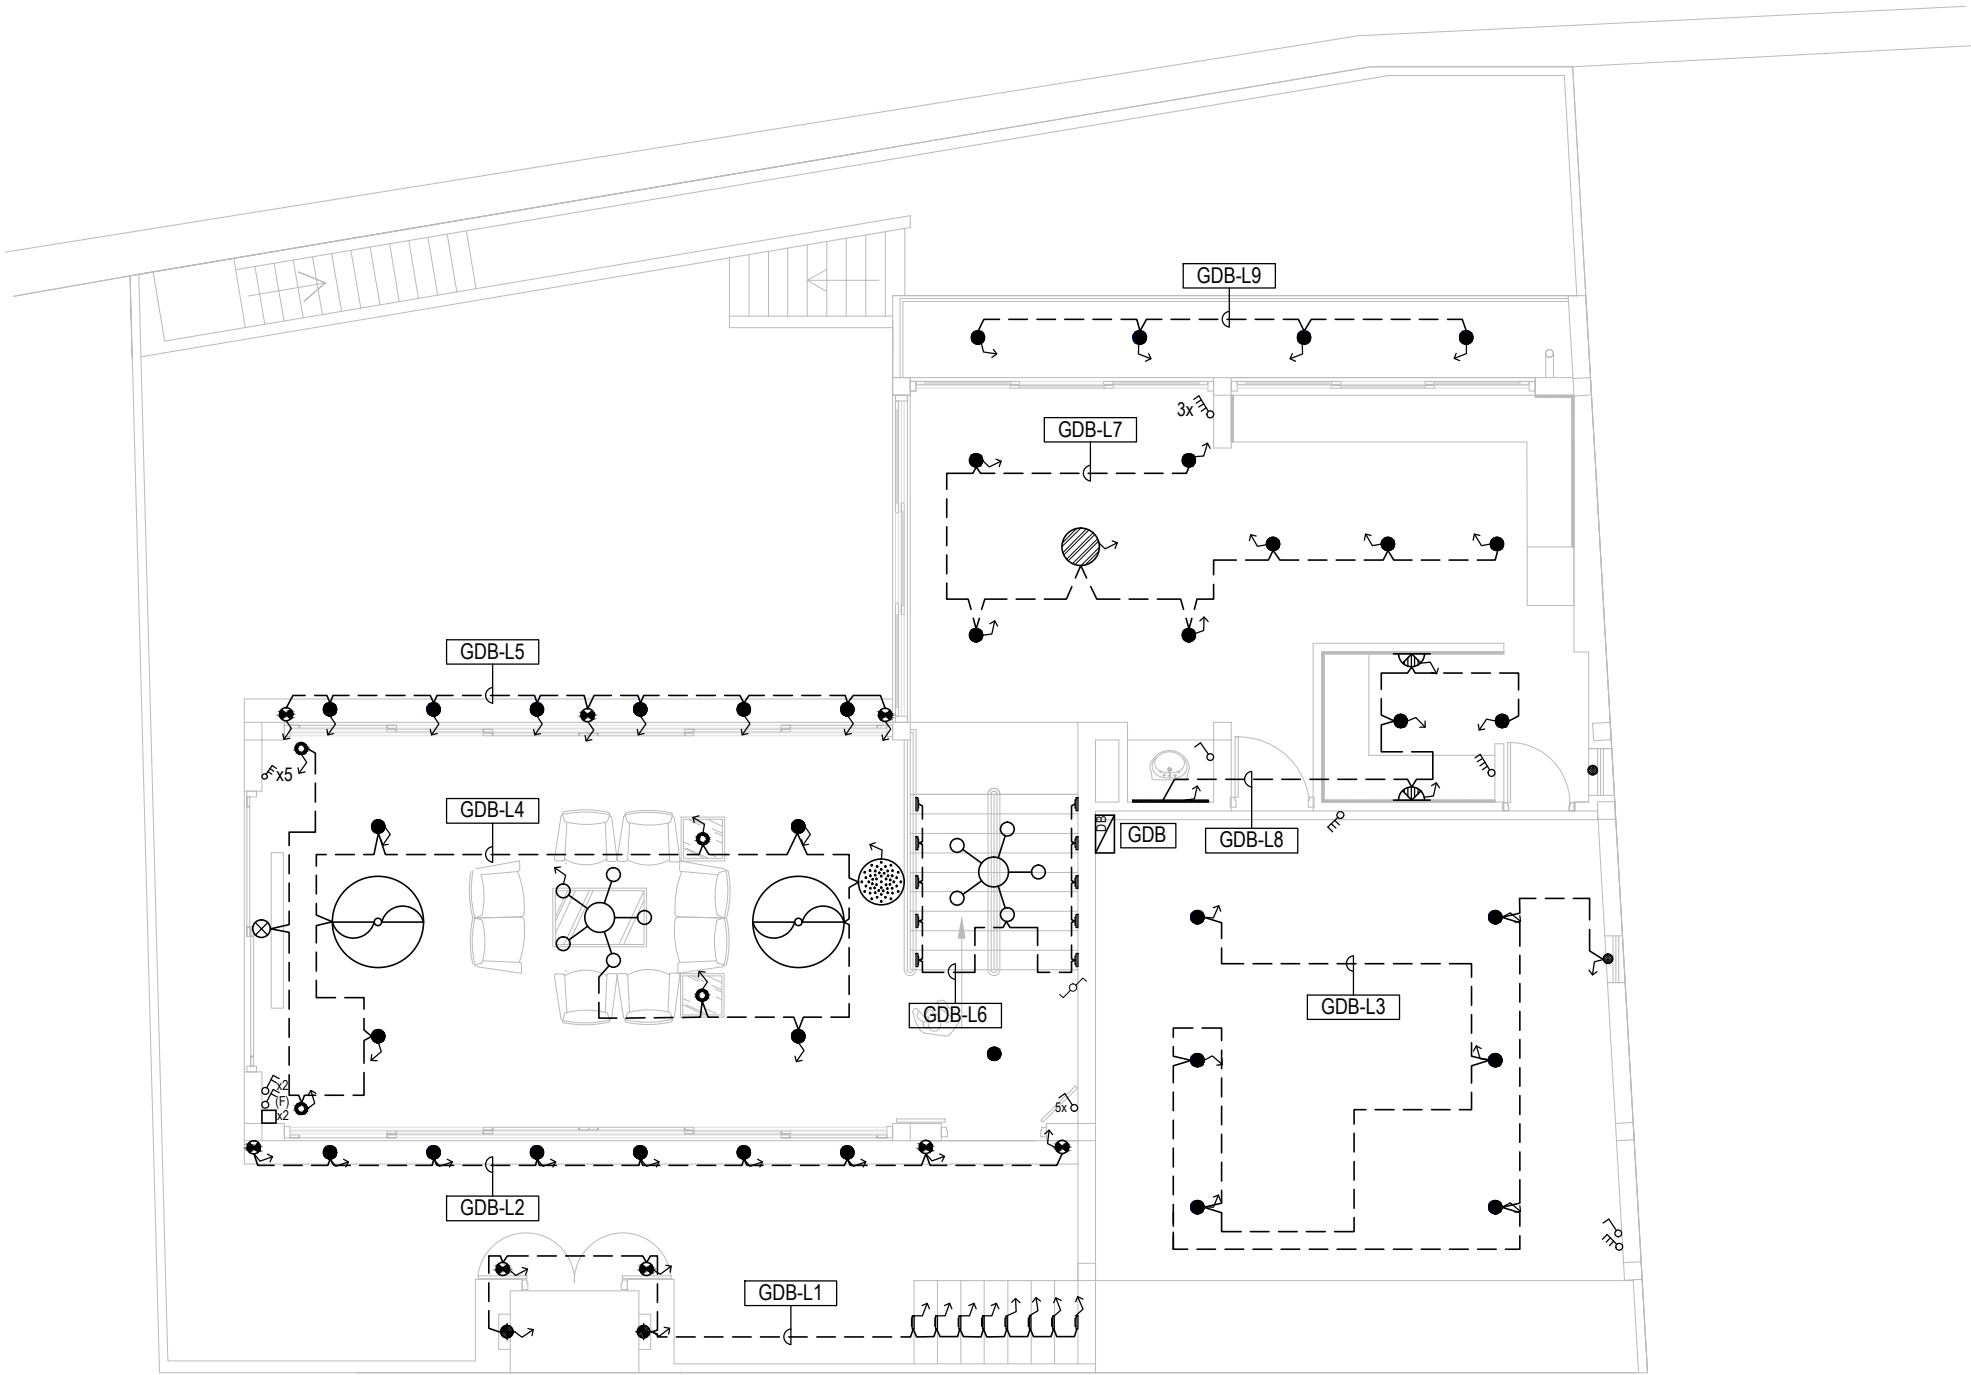

LEGEND

-  - DISTRIBUTION BOARD
-  - SOFFIT LIGHT
-  - FLOOR LIGHTS (@ floor)
-  - LIGHTS WITH SCULPTURE
-  - SOFA CONNER LAMPS
-  - PICTURE LIGHT @ WALL
-  - READING LAMP
-  - LIGHT ROBE EDGE TOP
-  - PENDANT LAMP
-  - LIGHT @ WINDOW SILL TOP SIDE
-  - STEP LAMP
-  - IN SIDE WALL LAMP
(Lamp at 7'-0" above from floor)
-  - CHANDLIER
-  - FAN
-  - ONE GANG SWITCH
-  - TWO GANG SWITCH
-  - THREE GANG SWITCH
-  - FOUR GANG SWITCH
-  - TWO WAY SWITCH

Drawing Title

ELECTRICAL INSTALLATION
LIGHTING LAYOUT
GROUND FLOOR

Client

ROPOSED RESIDENTIAL BUILDING FOR DR. KUMARA
AT HAPUGALA, GALLE

Design By : J.G.D.S.DE SILVA,
Electrical Engineer,
Bsc(Hon),
C.Eng.,MIE(SL).

Signature :

Mobile No. : 071-3121235.

Date : 13-11-2020.

Drawing Number
ELE - LGHT - 01

Scale
N.T.S.

Sheet Size
A3

Page Number
06

Rev

Date

Description

Stat.

Remarks