


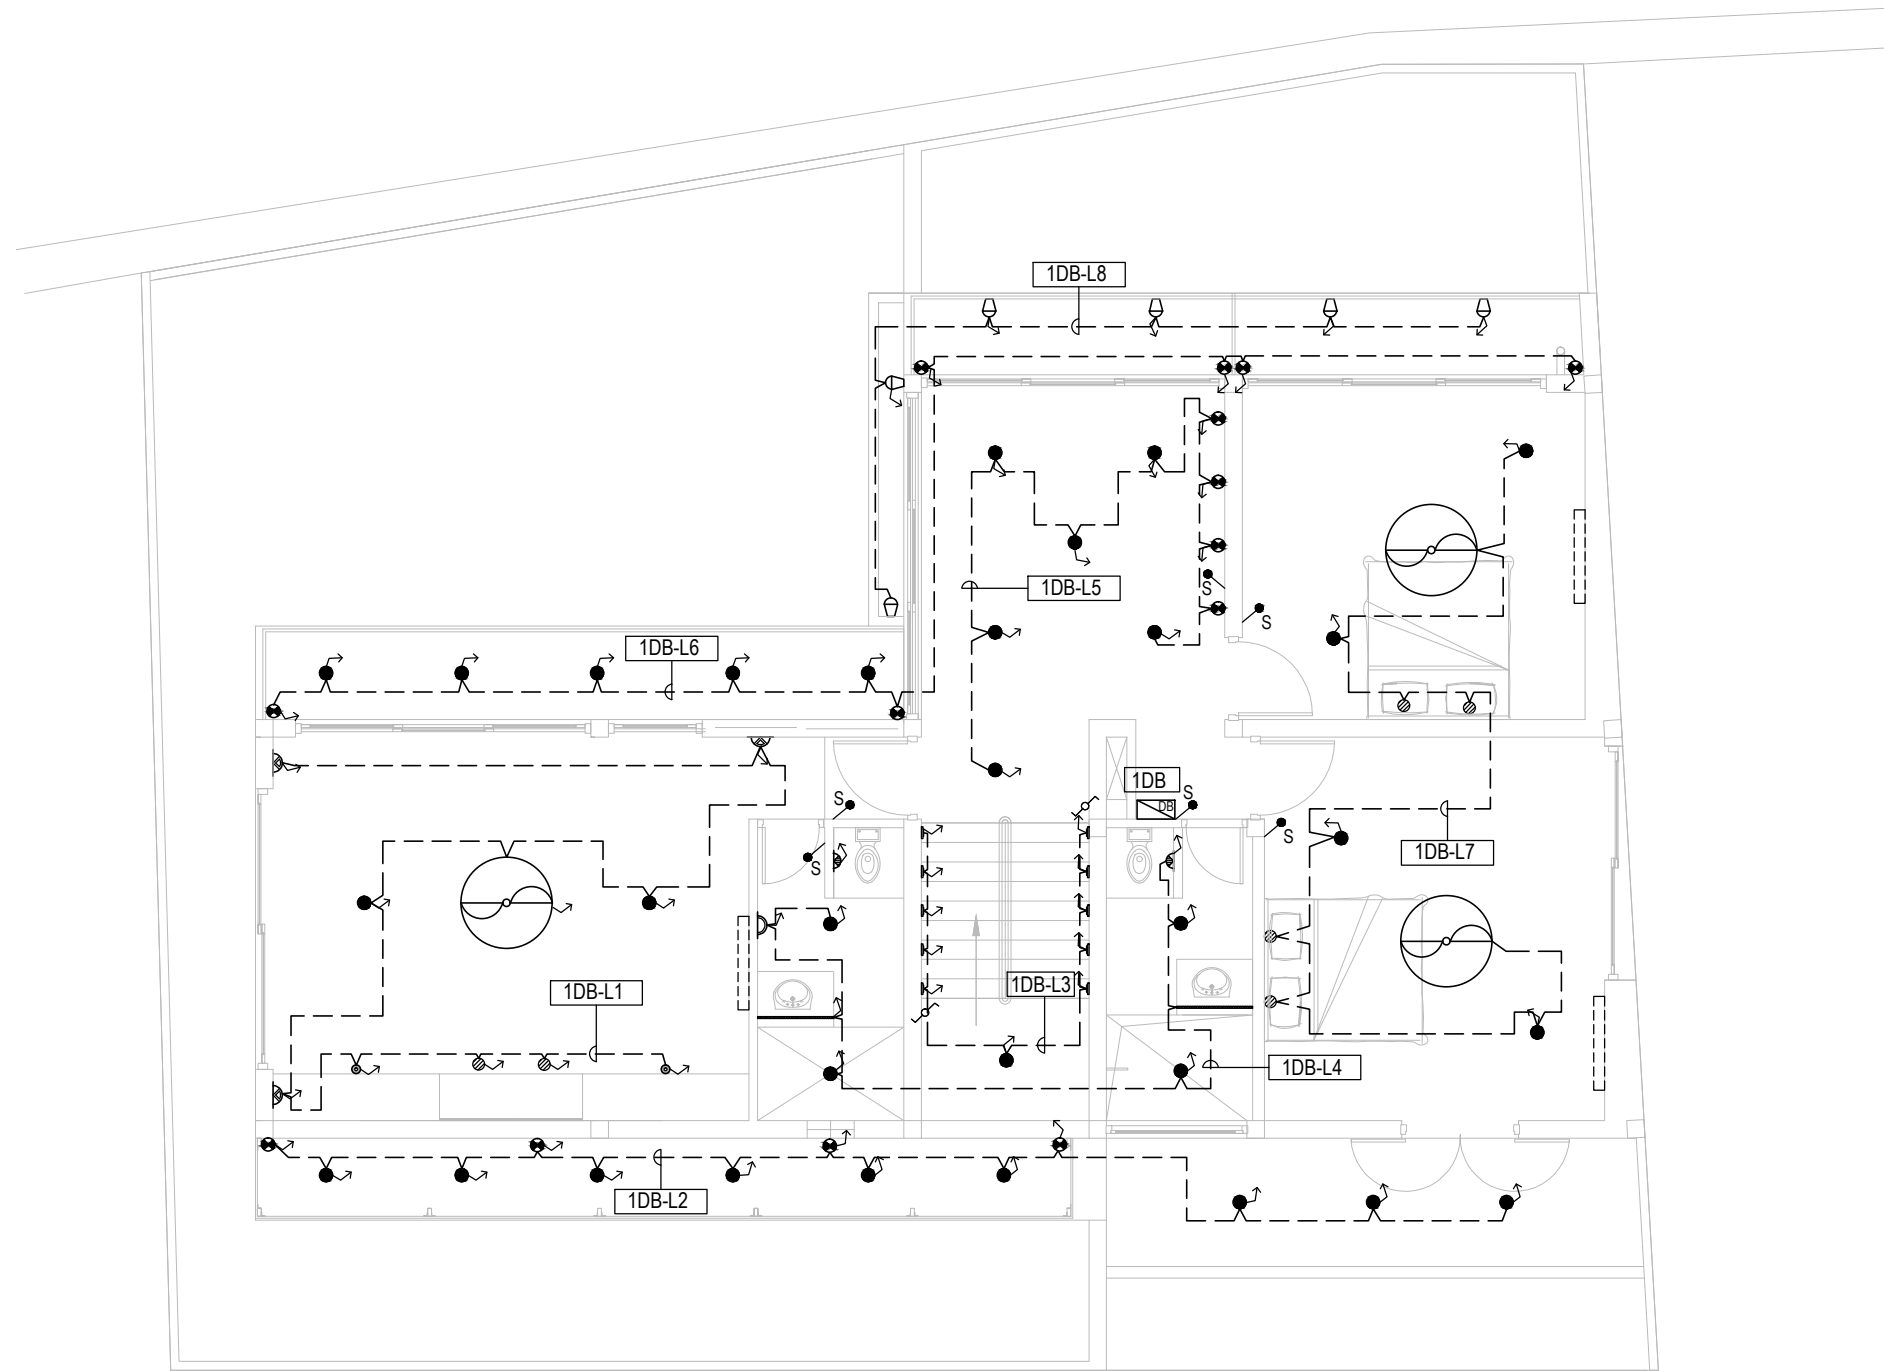

LEGEND

- DISTRIBUTION BOARD
- SOFIT LIGHT
- FLOOR LIGHTS (@ floor)
- READING LAMP
- LIGHT ROBE EDGE TOP
- STEP LAMP
- IN SIDE WALL LAMP (Lamp at 0'-4" above from floor)
- IN SIDE WALL LAMP (Lamp at 2'-0" above from floor)
- IN SIDE WALL LAMP (Lamp at 10'-0" above from floor)
- GARDEN LAMP (Lamp at 1'-0" above from finish floor level)
- SWITCHES
- TWO WAY SWITCHES
- FAN

Drawing Title

ELECTRICAL INSTALLATION LIGHTING LAYOUT FIRST FLOOR

Client

ROPOSED RESIDENTIAL BUILDING FOR DR. KUMARA
AT HAPUGALA, GALLE

Design By : J.G.D.S.DE SILVA,
Electrical Engineer,
Bsc(Hon),
C.Eng.,MIE(SL).

Signature :

Mobile No. : 071-3121235.

Date : 13-11-2020.

Drawing Number
ELE - LGHT - 02

Scale
N.T.S.

Sheet Size
A3

Page Number
08

Rev

Date

Description

Stat.

Remarks