


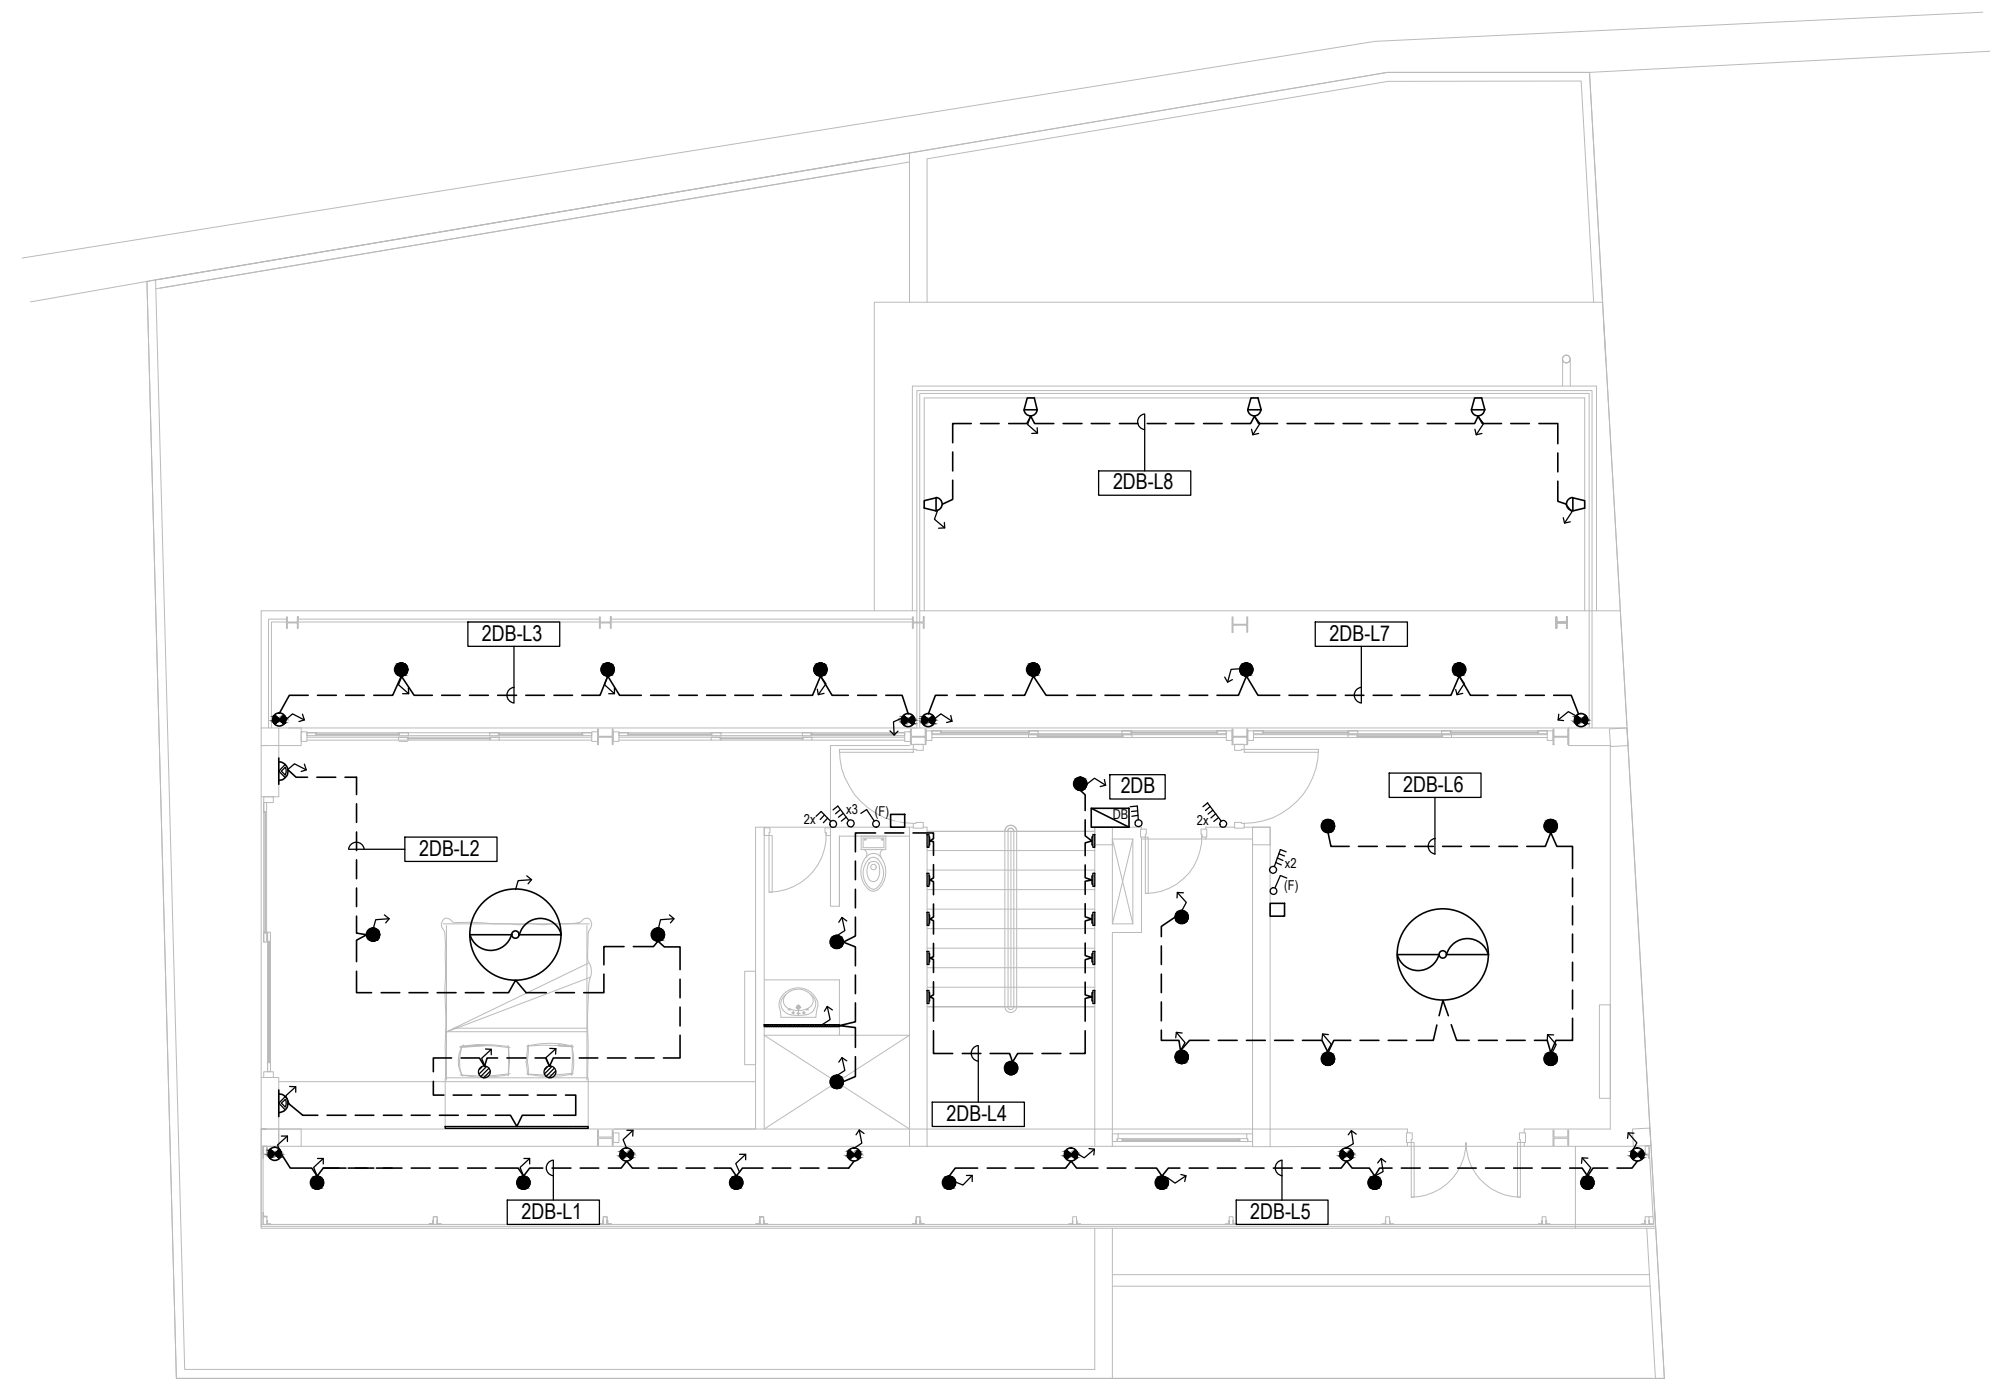

LEGEND

-  - DISTRIBUTION BOARD
-  - SOFFIT LIGHT
-  - FLOOR LIGHTS (@ floor)
-  - LIGHTS WITH SCULPTURE
-  - SOFA CONNER LAMPS
-  - PICTURE LIGHT @ WALL
-  - READING LAMP
-  - LIGHT ROBE EDGE TOP
-  - PENDANT LAMP
-  - LIGHT @ WINDOW SILL TOP SIDE
-  - STEP LAMP
-  - IN SIDE WALL LAMP  
(Lamp at 7'-0" above from floor)
-  - CHANDLIER
-  - MIRROR LAMP
-  - BED LAMP
-  - FAN
-  - ONE GANG SWITCH
-  - TWO GANG SWITCH
-  - THREE GANG SWITCH
-  - FOUR GANG SWITCH
-  - TWO WAY SWITCH

Drawing Title

**ELECTRICAL INSTALLATION  
LIGHTING LAYOUT  
SECOND FLOOR**

Client

ROPOSED RESIDENTIAL BUILDING FOR DR. KUMARA  
AT HAPUGALA, GALLE

Design By : J.G.D.S.DE SILVA,  
Electrical Engineer,  
Bsc(Hon),  
C.Eng.,MIE(SL).  
  
Signature : .....  
Mobile No. : 071-3121235.  
Date : 13-11-2020.

Drawing Number  
ELE - LGHT - 03

Scale  
N.T.S.

Sheet Size  
A3

Page Number  
10

| Rev | Date | Description | Stat. | Remarks |
|-----|------|-------------|-------|---------|
|     |      |             |       |         |
|     |      |             |       |         |
|     |      |             |       |         |
|     |      |             |       |         |